


BUILDING SECTION A-A


SCALE: 1/4" = 1'-0"

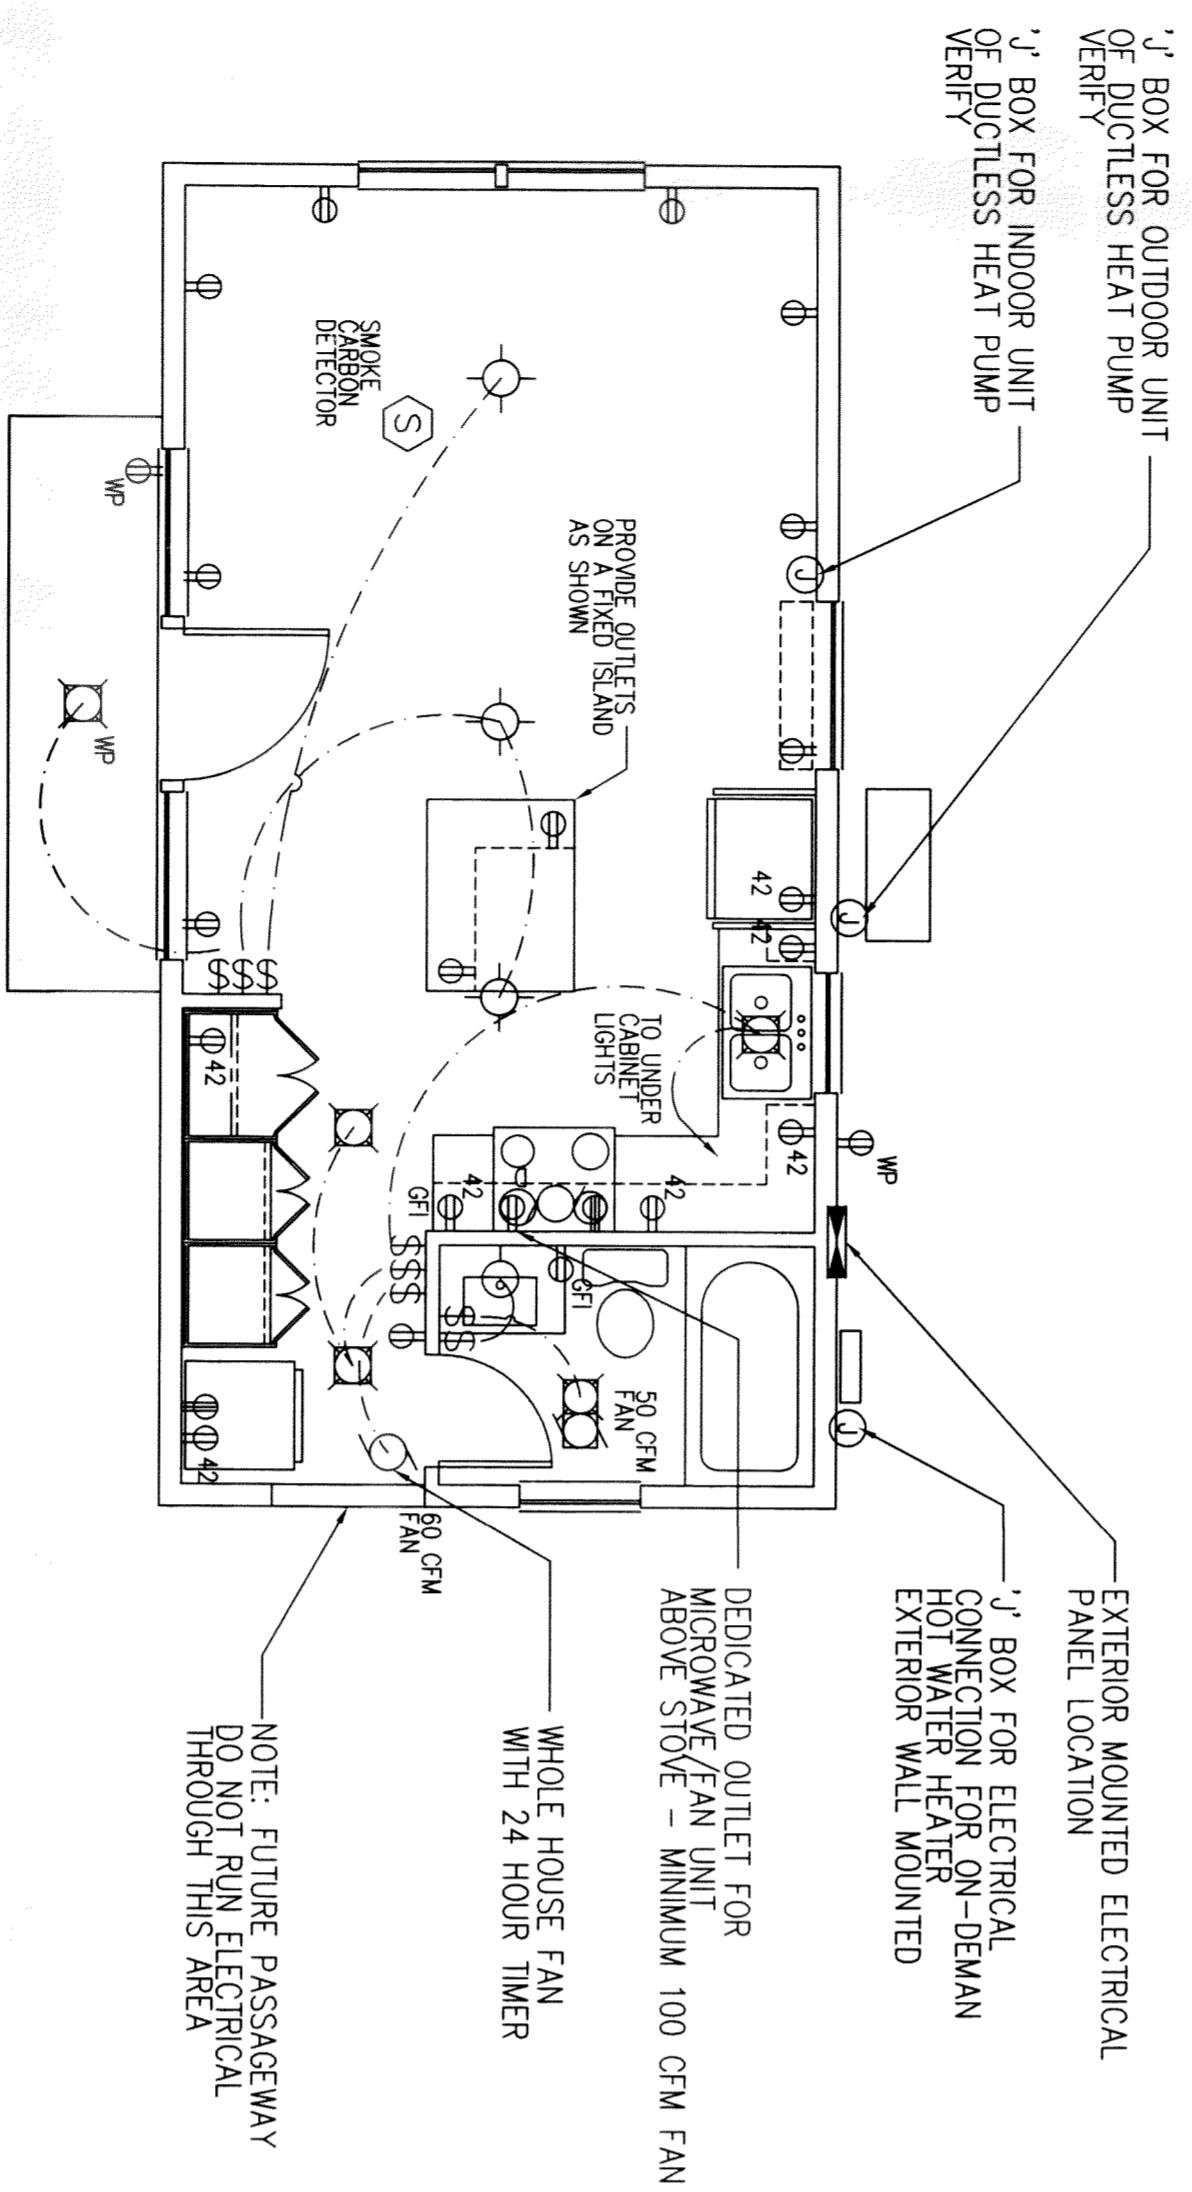

ELECTRICAL PLAN


SCALE: 1/4" = 1'-0"

MK	DESCRIPTION	REMARKS
⊖	110 V CONVENIENCE OUTLET	
⊖WP	110 V CONVENIENCE OUTLET - WATERPROOF	
⊖GFI	110 V CONVENIENCE OUTLET - GROUND FAULT	
⊖	220 V OUTLET	
⊖	CEILING MOUNTED SURFACE LIGHT FIXTURE	
⊖	WALL MOUNTED SURFACE LIGHT FIXTURE	
⊖	CEILING RECESSED CAN FIXTURE	
⊖	RECESSED CEILING-MOUNT FAN/HEAT LIGHT COMBO	
⊖	SWITCH	
⊖	TELEPHONE OUTLET	
⊖	TELEVISION OUTLET	
⊖	ELECTRICAL PANEL	

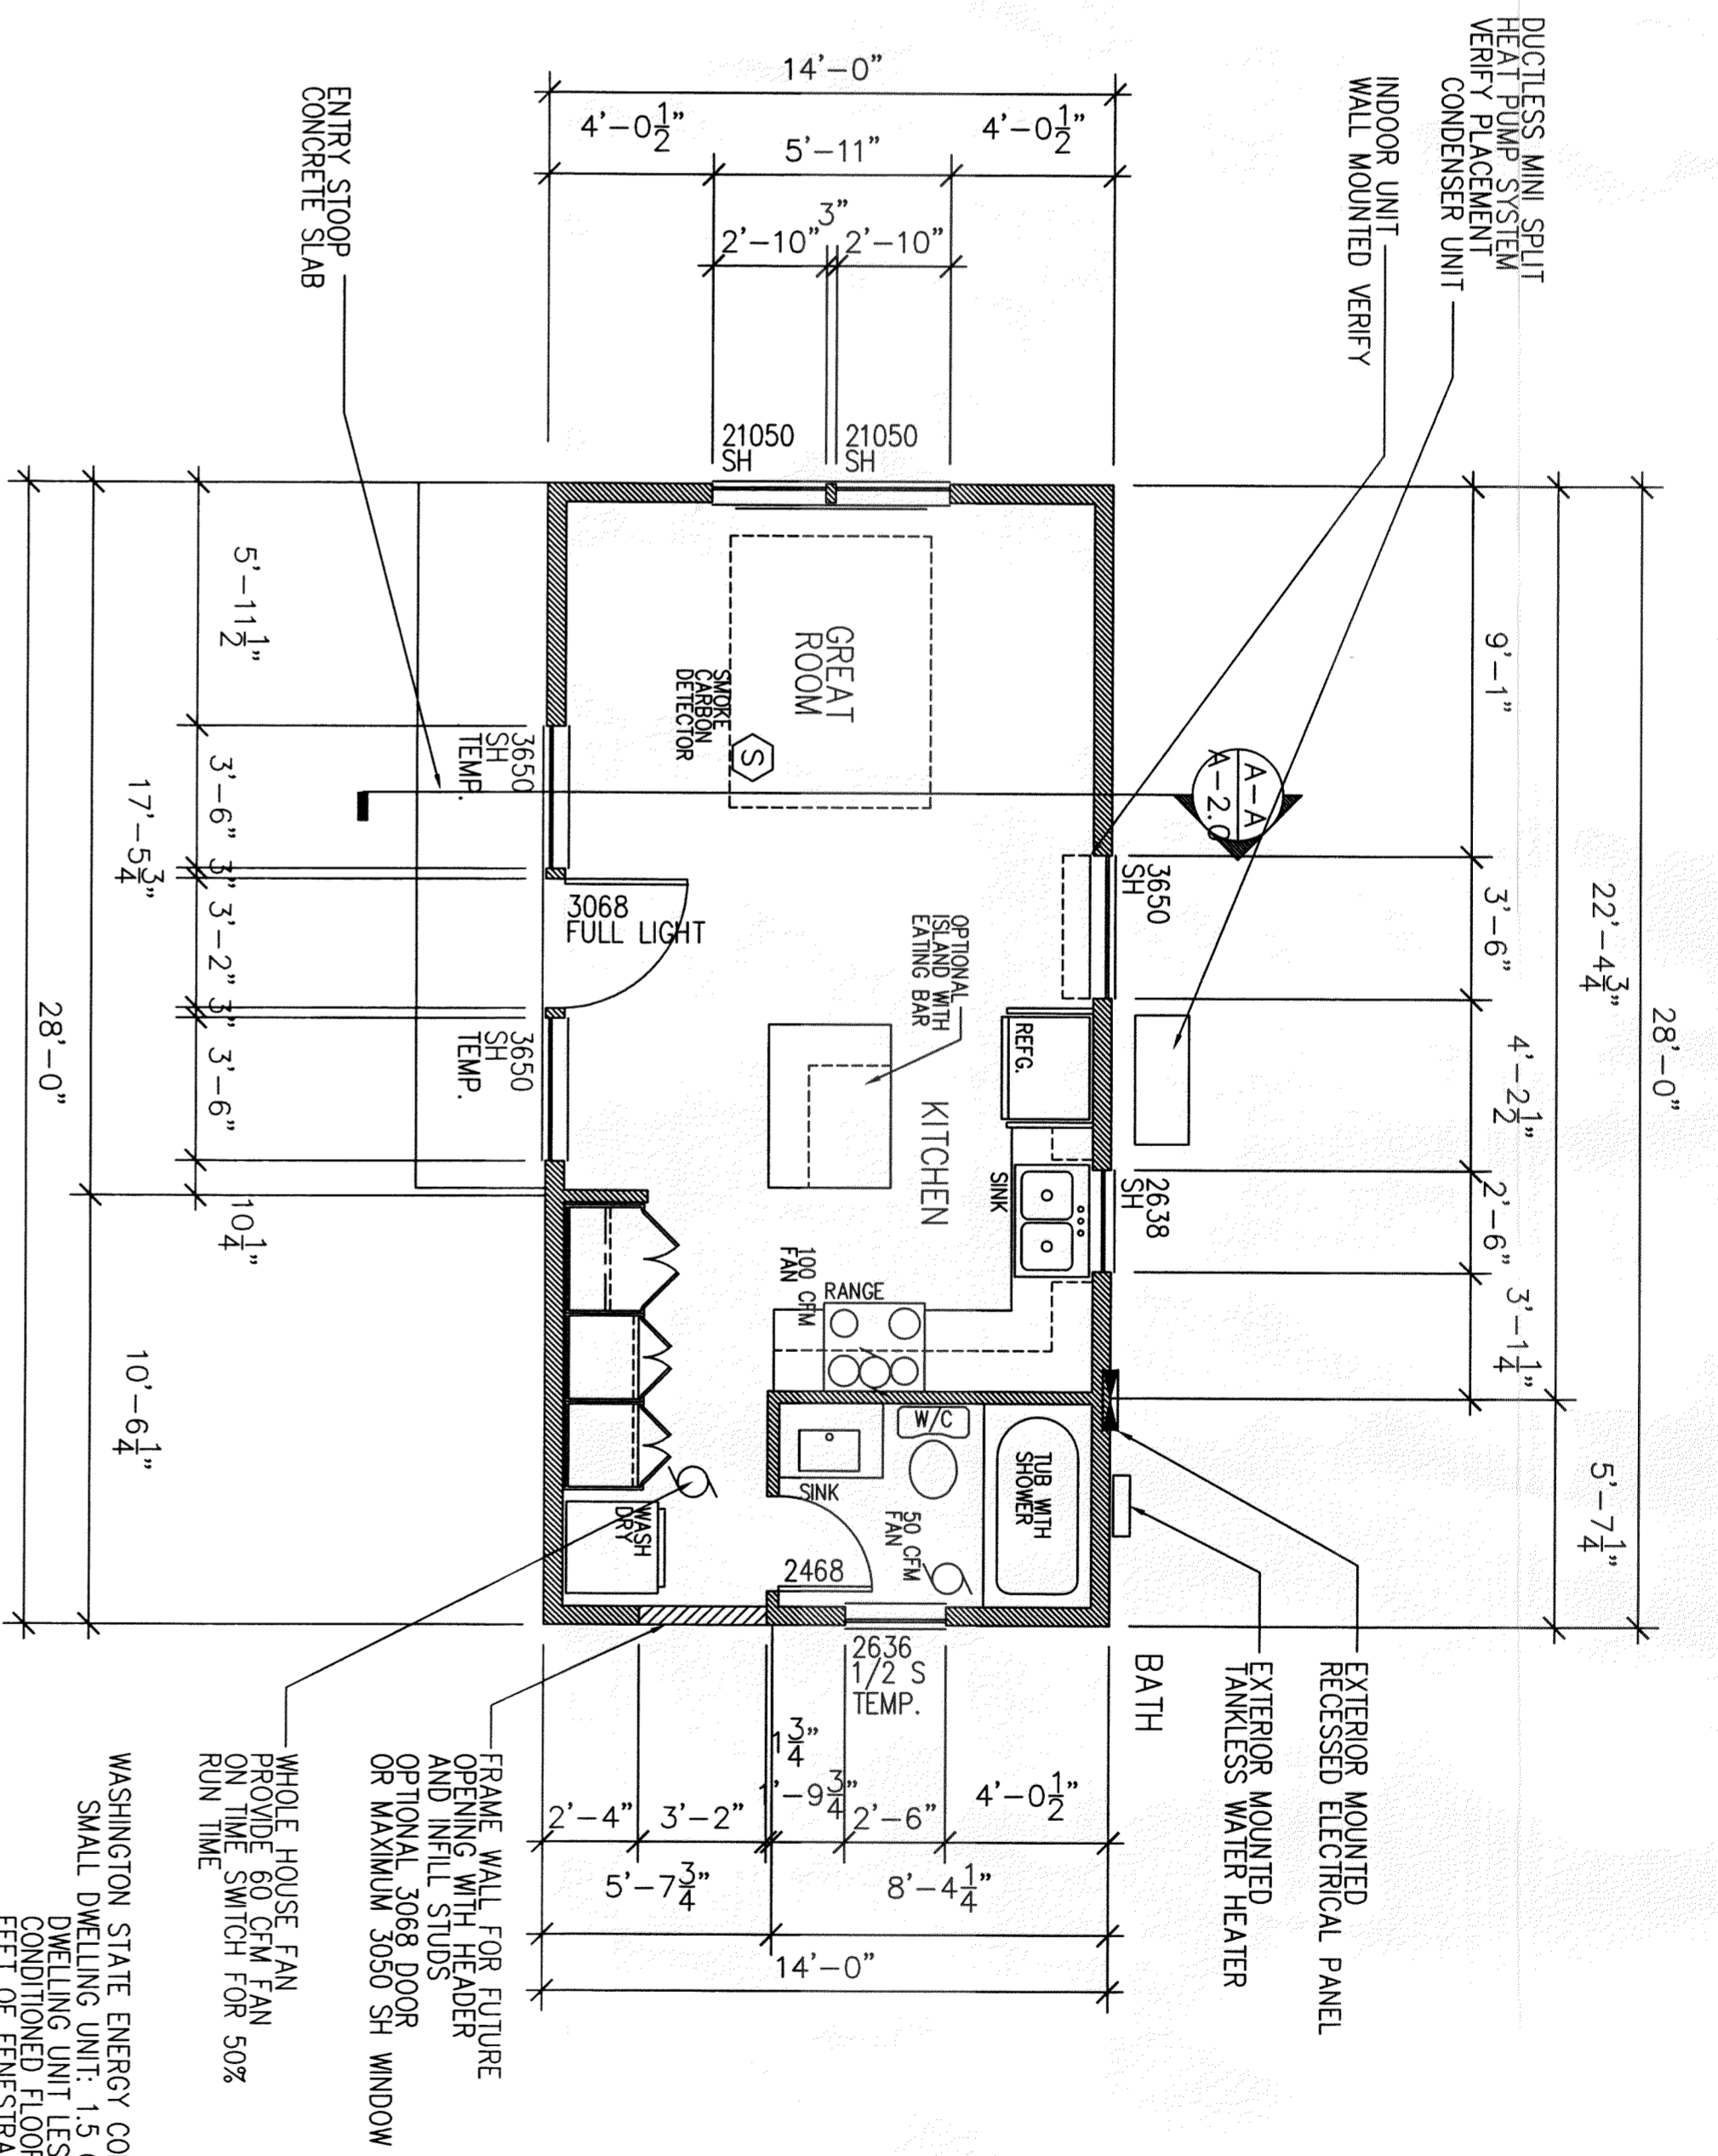

FLOOR PLAN

SCALE: 1/4" = 1'-0"

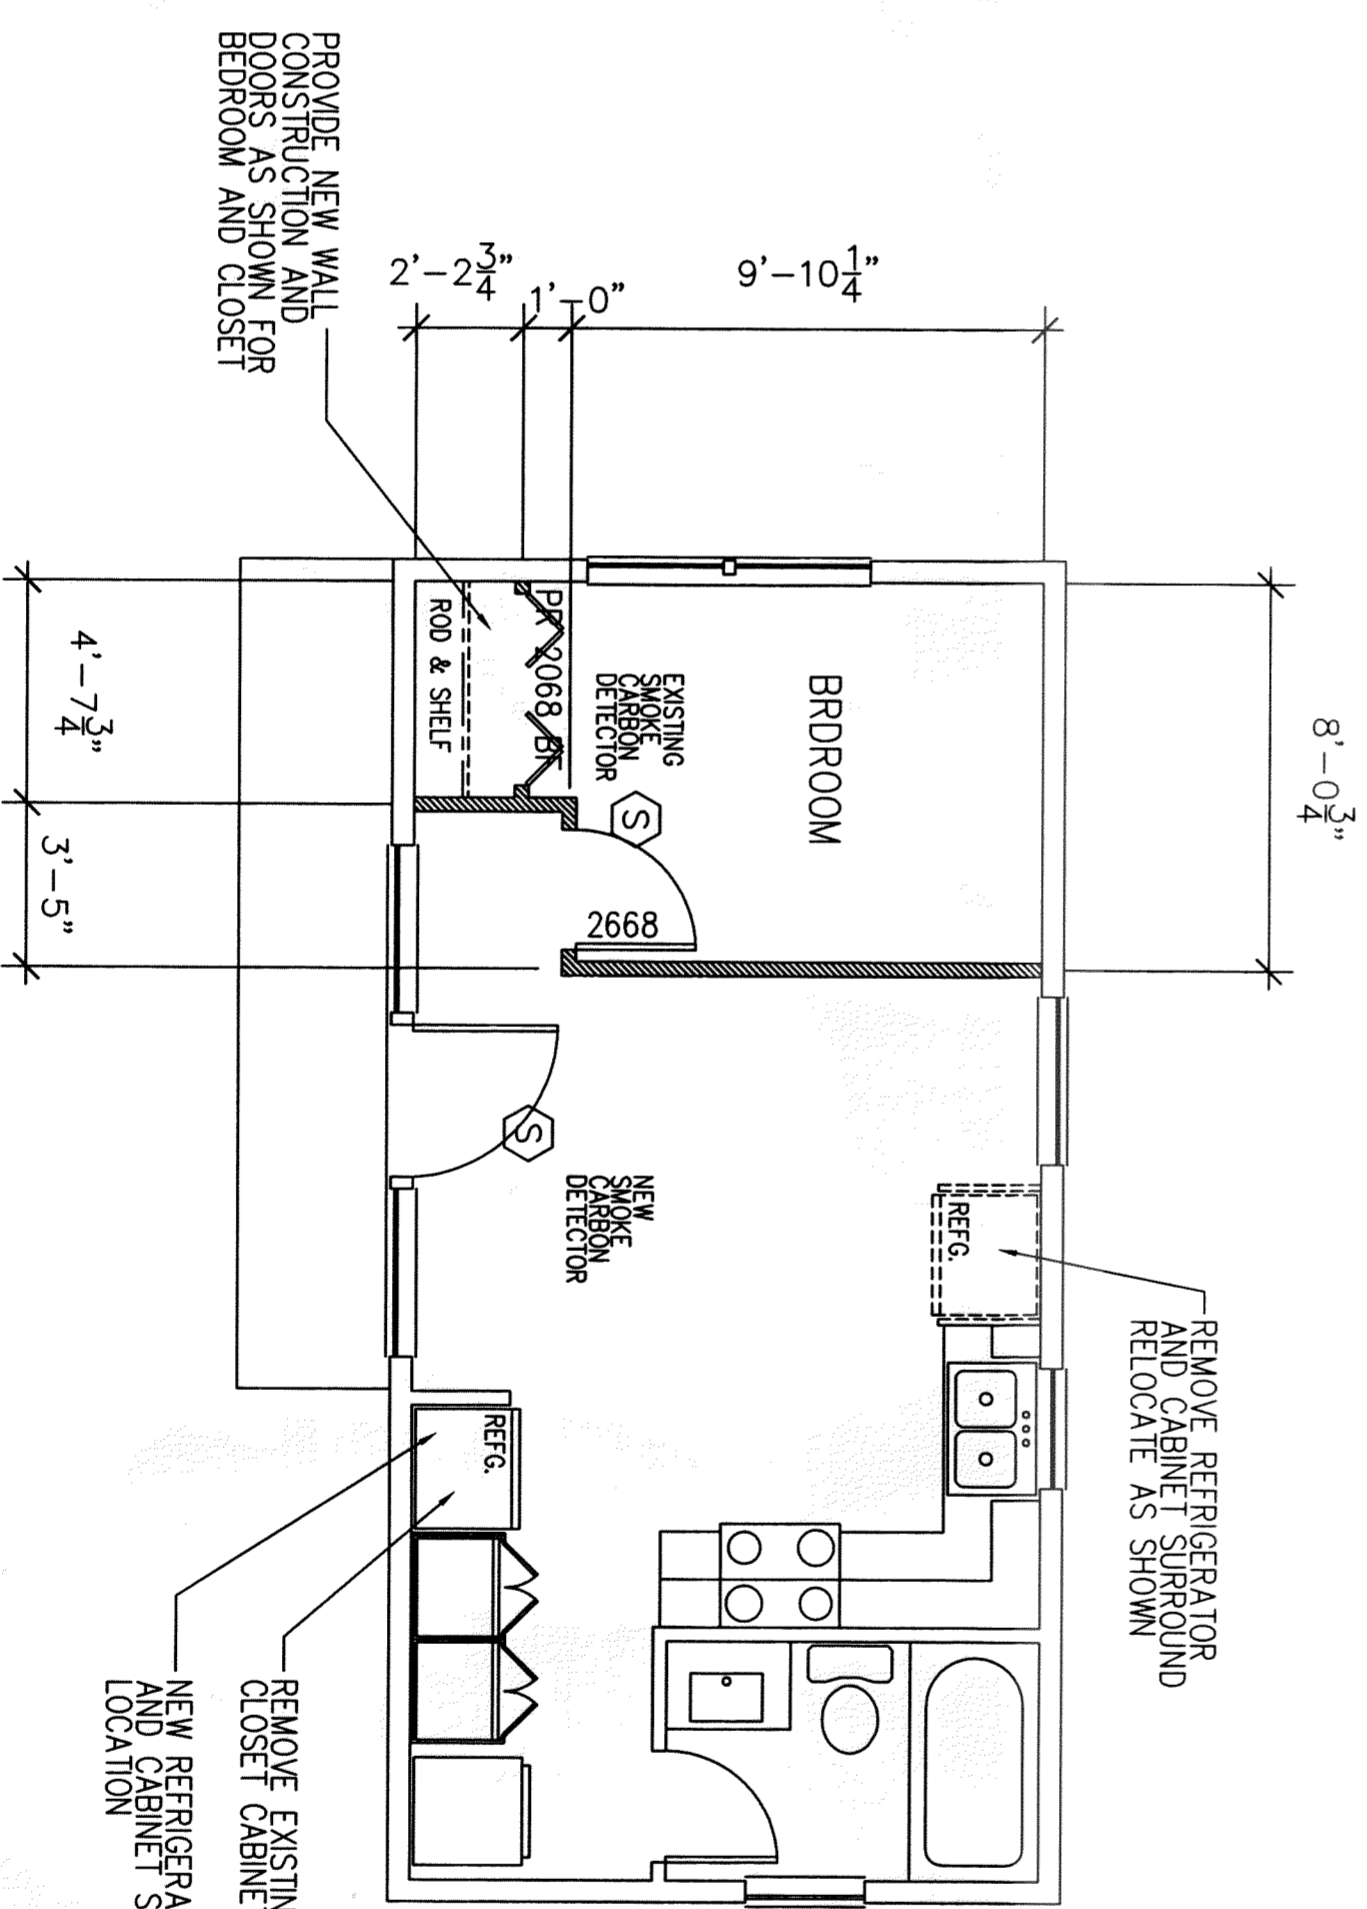

FLOOR PLAN WITH ALTERNATE BEDROOM

SCALE: 1/4" = 1'-0"

DRAWING INDEX	
A-1.0	FLOOR PLAN, BUILDING SECTION ELECTRICAL PLAN
A-2.0	EXTERIOR ELEVATIONS DETAILS
A-3.0	FOUNDATION, BRACE WALL PLAN ROOF FRAMING PLAN DETAILS
A-4.0	WALL FRAMING ELEVATIONS STRUCTURAL GENERAL NOTES